


Sage College



Temple Beth Emeth

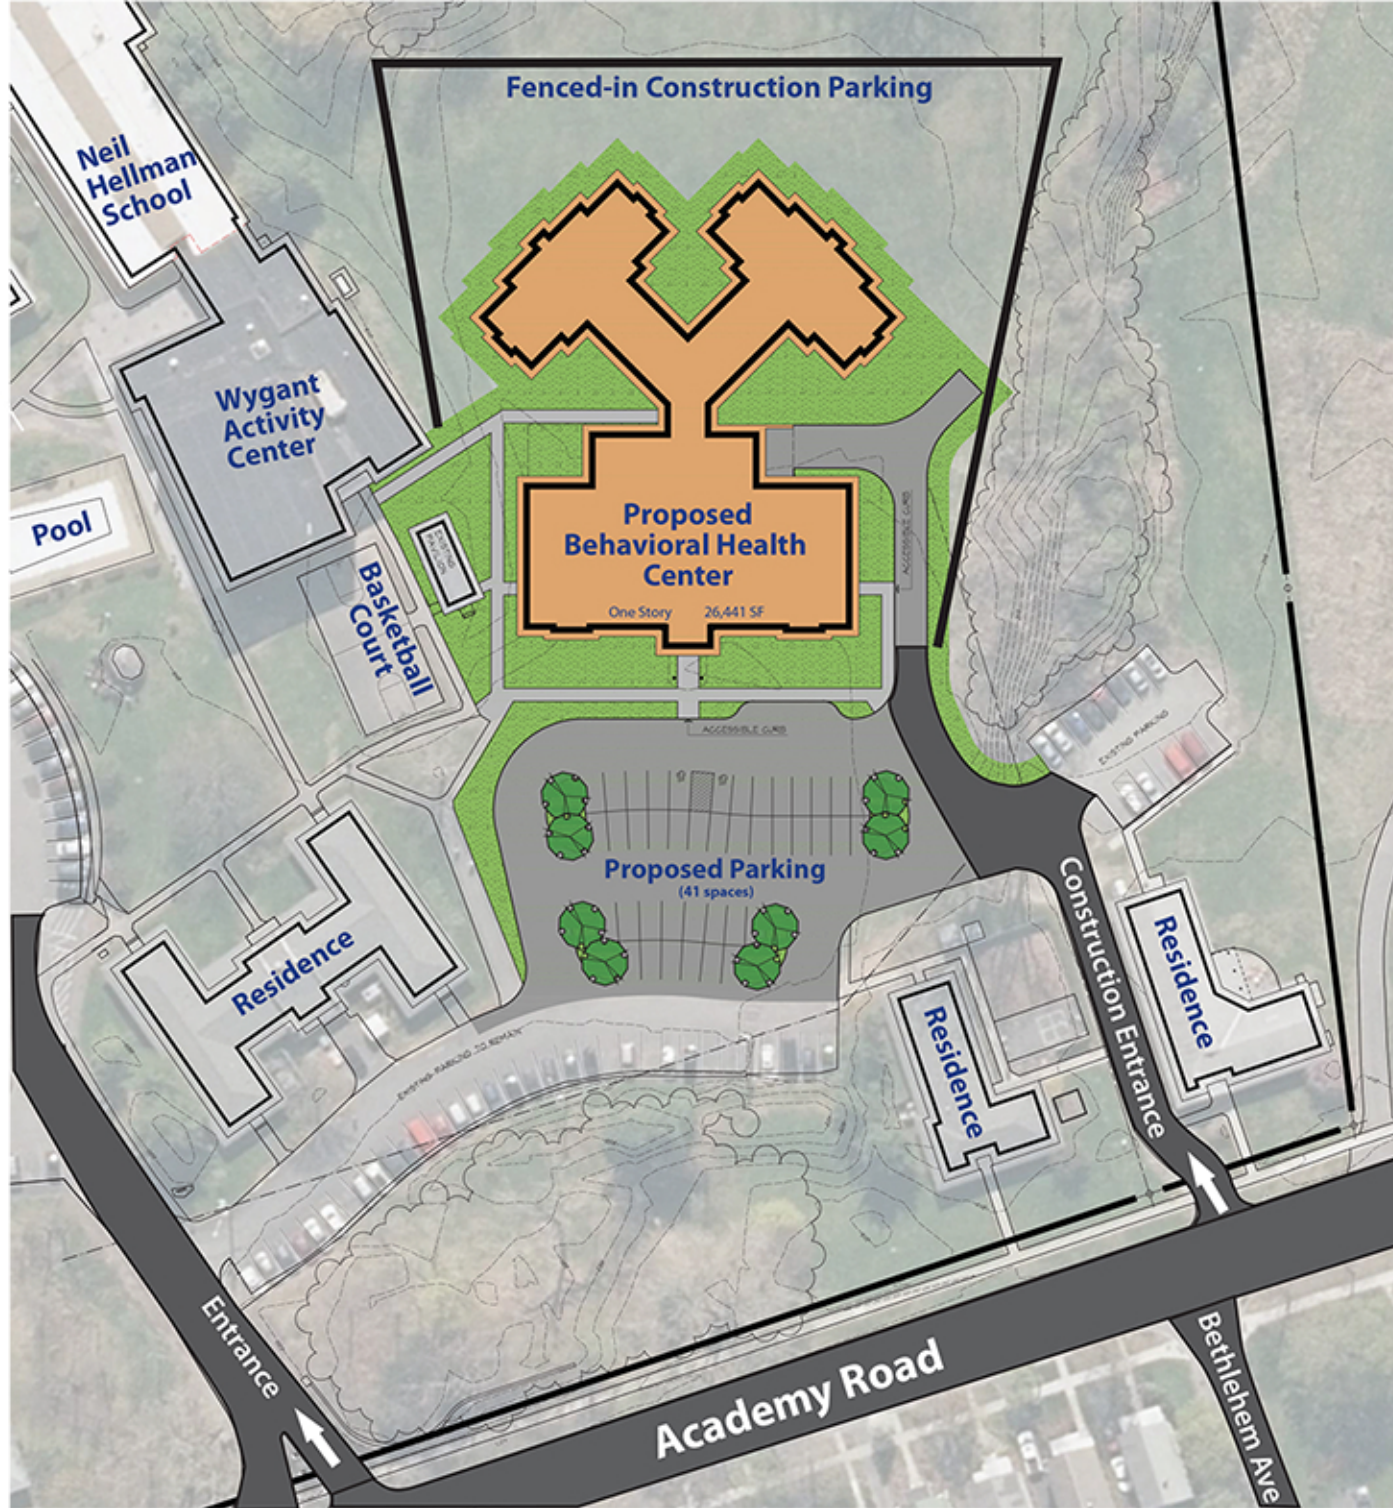

ARCHITECTURE / INTERIOR DESIGN
WCGS ARCHITECTS
300 CORPORATE WOODS BOLLINGWOOD ALBANY, NEW YORK 12211
HUSTON ENGINEERING
100 NATIONAL STREET, SUITE 200
ROCHESTER, NEW YORK 14610



PROJECT LOCATION: 100 WOODS BOLLINGWOOD ALBANY, NY 12211
PROJECT NUMBER: 100-00-001
DATE: 06/20/2017

NORTHERN HAVENS FAMILY SERVICES
BEHAVIORAL HEALTH CENTER
80 BROADWAY ROAD
ALBANY, NEW YORK
PARTIAL
CONCEPT SITE PLAN
SCALE: PRINTED 8/1 X 3/17
1" = 50'

